
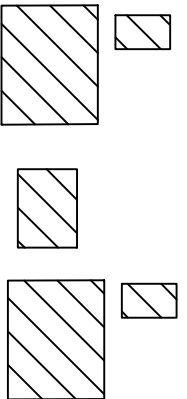
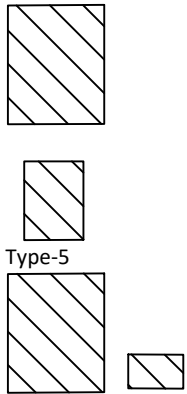


Type-4

Way To Visitor Hostel

Way To Visiting Faculty Apartment

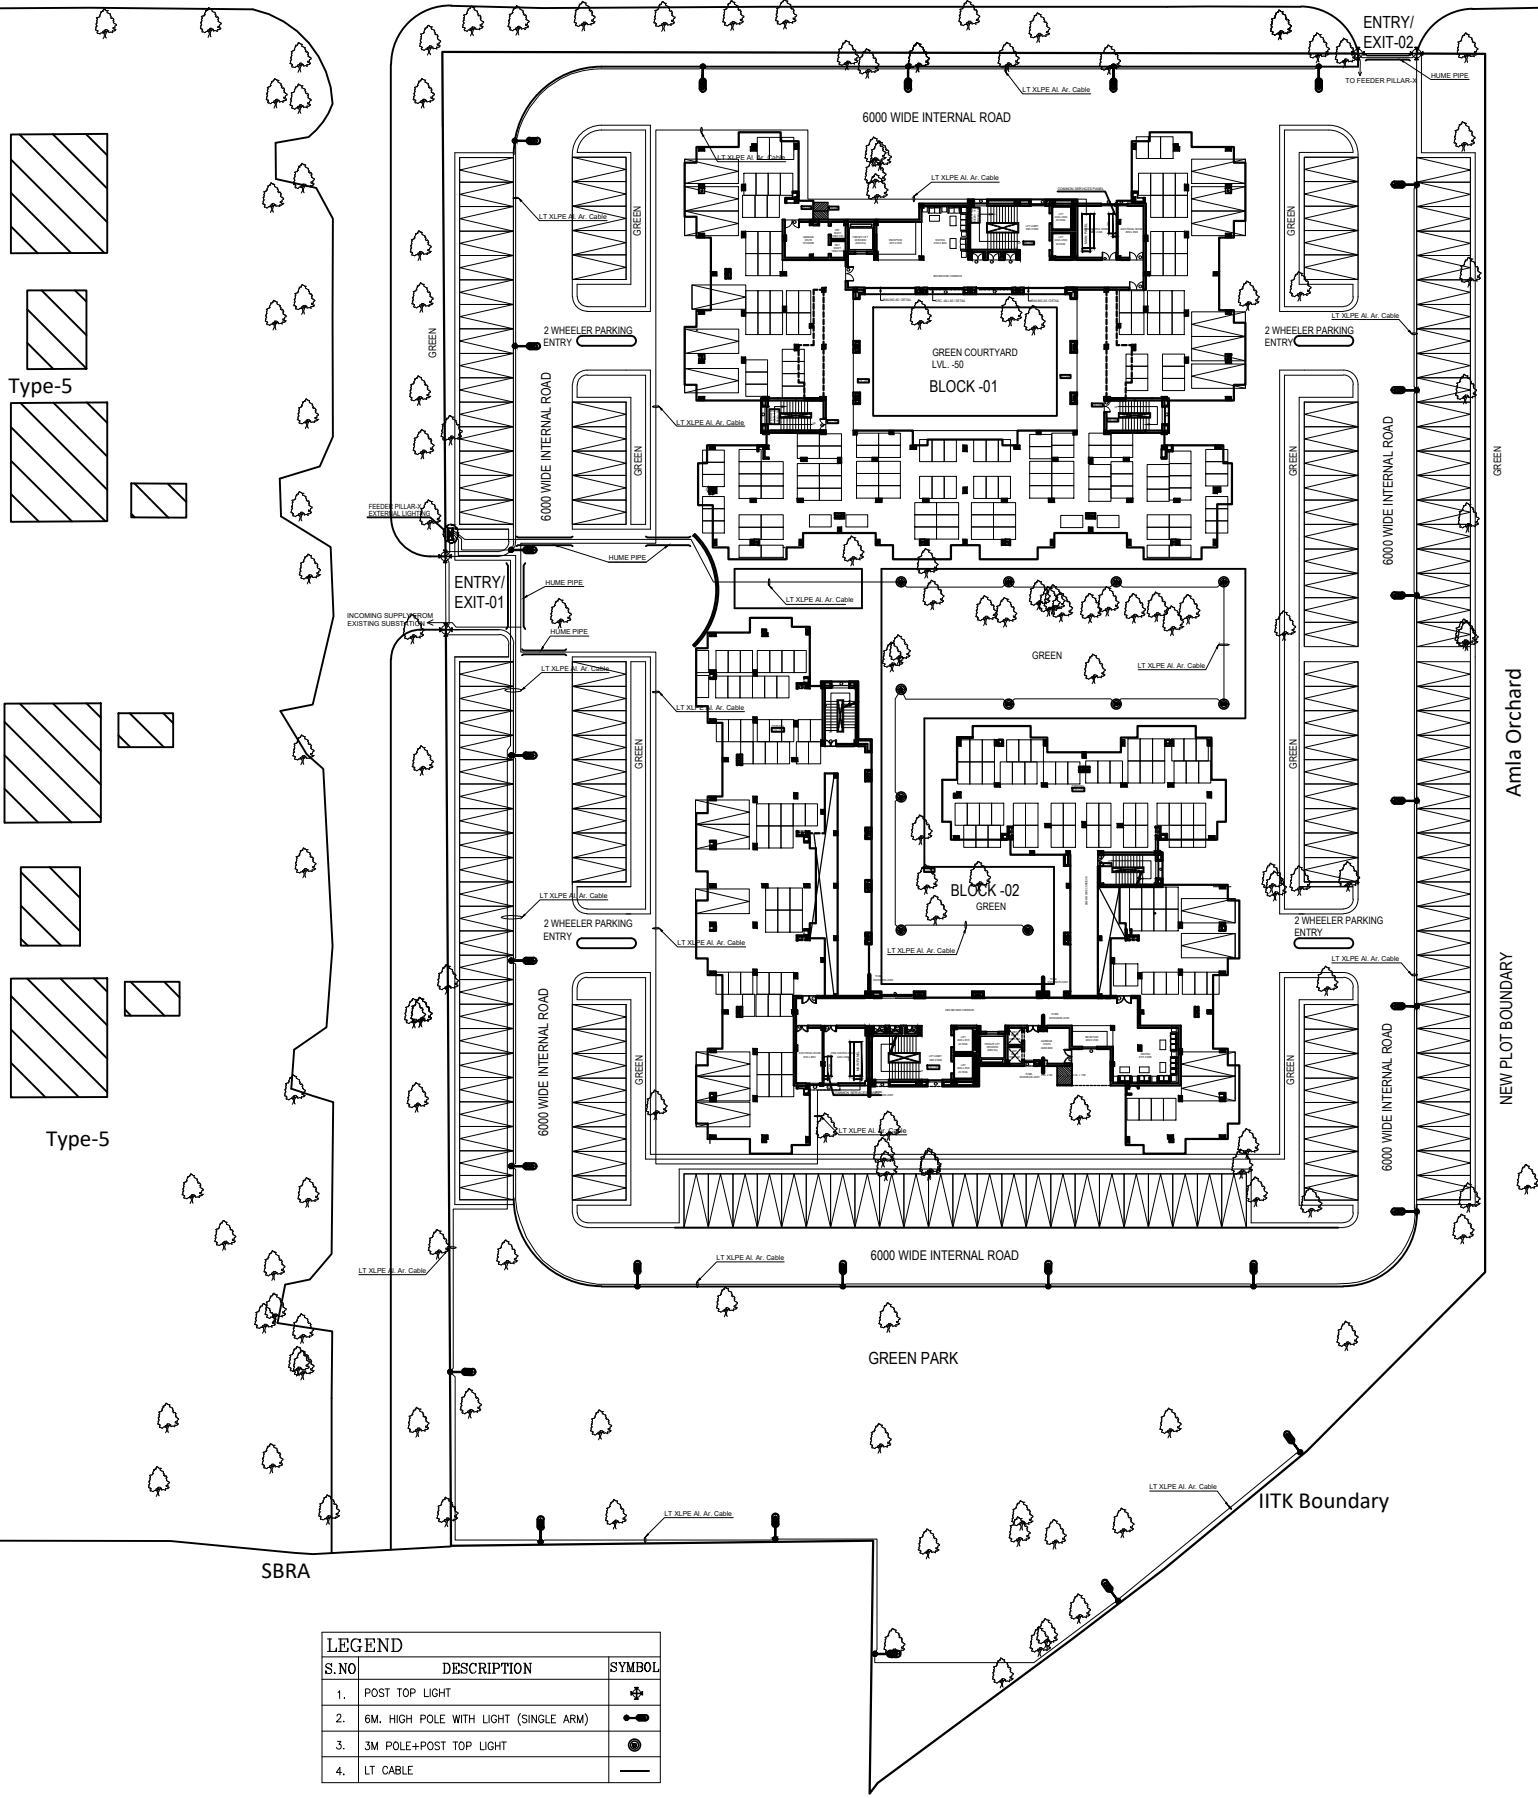

LEGEND		
S.NO	DESCRIPTION	SYMBOL
1.	POST TOP LIGHT	+
2.	6M. HIGH POLE WITH LIGHT (SINGLE ARM)	⊙
3.	3M POLE+POST TOP LIGHT	⊙
4.	LT CABLE	—

PROJECT:
PROPOSED TYPE-III HOUSING AT I.I.T. KANPUR

NOTES:
1- ALL DIMENSIONS IN MILLIMETER UNLESS OTHERWISE SPECIFIED.
2- FIGURE DIMENSIONS SHALL BE FOLLOWED.
3- ALL DIMENSIONS SHALL BE CHECKED & VERIFIED BEFORE COMMENCEMENT OF THE WORK.
4- DISCREPANCY, IF ANY, SHALL BE BROUGHT TO THE NOTICE OF ARCHITECT IN-CHARGE AND CLARIFICATION OBTAINED IN WRITING PRIOR TO EXECUTION OF THE WORK.

DRG. TITLE:
EXTERNAL ELECTRICAL LAYOUT (SITE PLAN)

CLIENT:
I.I.T. KANPUR

DRAWING STATUS :
TENDER DRAWINGS

DATE: APR.-2019 SCALE: 1:300 @ A1

DRG. NO. :
AED/IIT/WD/SITE/EL/01

NORTH :

CONSULTING ARCHITECTS:

ARCH-EN DESIGN
Architect **ASHOK KUMMAR**
14/2/01 - 14/01/2019, 14/01/2019, 14/01/2019
14/01/2019, 14/01/2019, 14/01/2019
14/01/2019, 14/01/2019, 14/01/2019