


FIRE ALARM SYSTEM

SYMBOL	DESCRIPTION
[S]	MULTI SENSOR DETECTOR (TRUE CEILING)
(S)	MULTI SENSOR DETECTOR (FALSE CEILING)
△S	MULTI SENSOR DETECTOR (BELOW FALSE FLOORING)
[S]	RESPONSE INDICATOR
[S]	MULTI SENSOR DETECTOR
[M]	MANUAL BREAK GLASS
[FAP]	FIRE ALARM PANEL
[S]	SOUNDER CUM STROBER

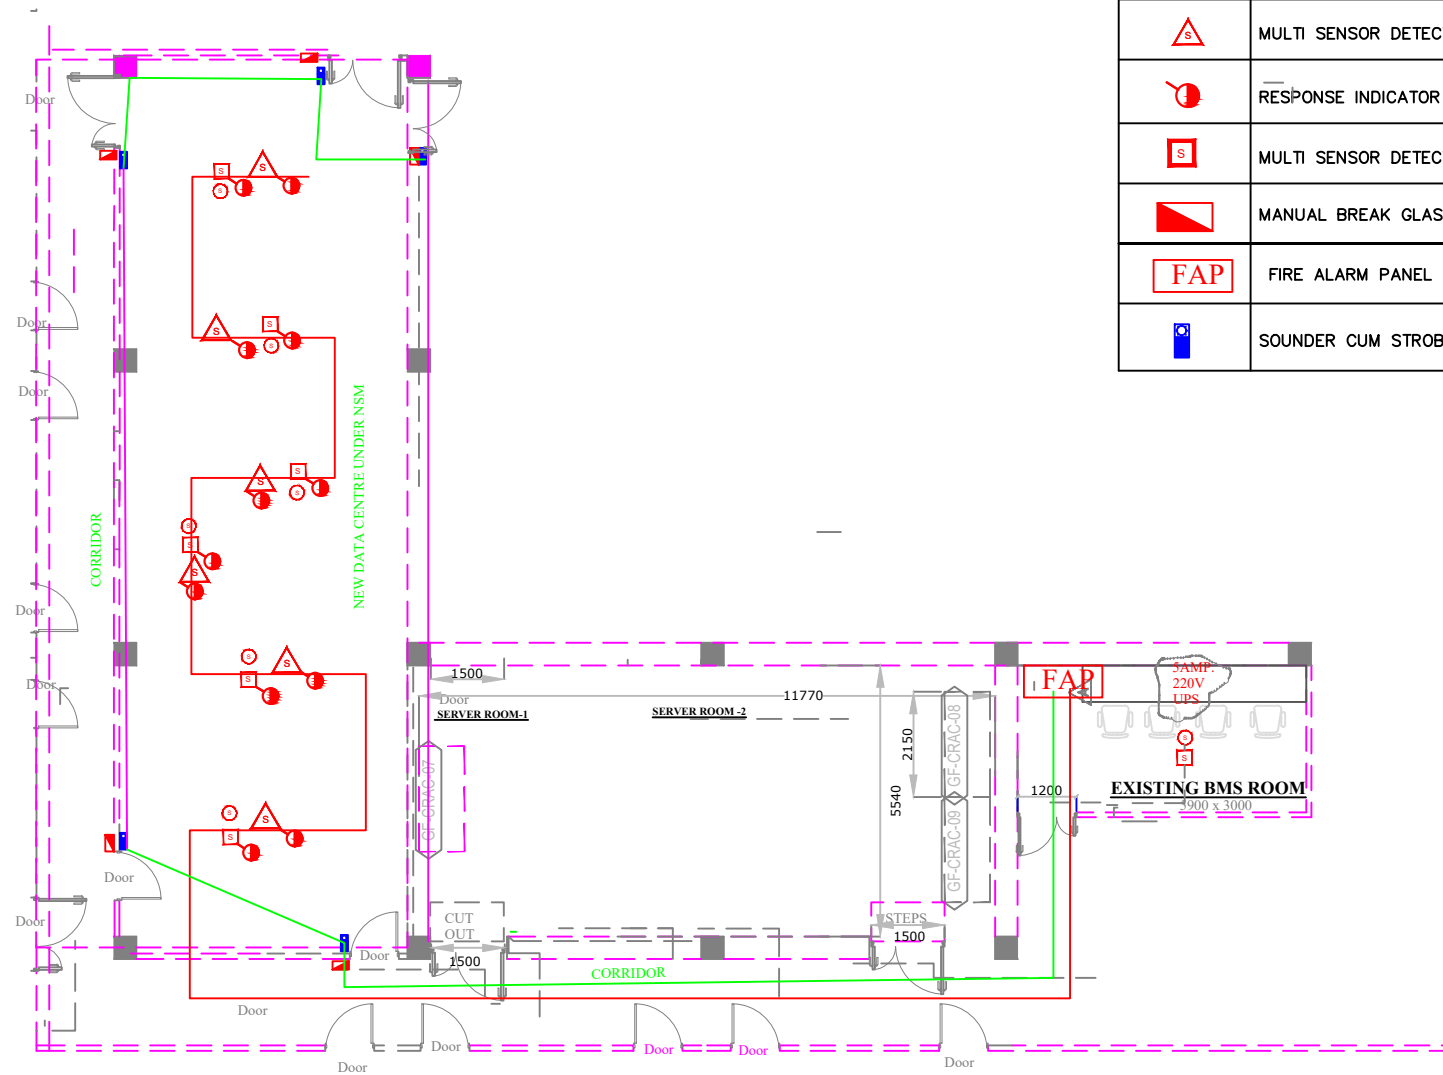

NAME OF PROJECT: HPC
FACILITY UNDER NSM at
COMPUTER CENTRE IIT
KANPUR

DRAWING: FIRE ALARM
SYSTEM LAYOUT

DRAWING NO. :
HPC-NSM-BMS-01

PREPARED BY: IIT KANPUR